


No	DESCRIPTION	TECHNICAL DATA	UNIT	QUANTITY	Total Quantity
1	STREET LIGHTIN	WITH BULT IN CONTROL GEAR FOR LED LAMP 150W	P.C	1	18
3	LAMP	150W Natural 4000K IP65	P.C	1	
4	JUNCTION BOX	CONSISTING OF: 1-MINIATURE CIRCUIT BREAKER 10A 2-TEXTOLIT BOARD 150x75x8mm 3-TERMINAL STRIP WITH 5 TERMINALS	P.C P.C P.C	1 1 1	
5	Lighting base	L=9m t=3.3mm Galvanized Steel	P.C	1	
6	Lighting base Foundation	60*60*200 Bult=4*Ø24	P.C	1	

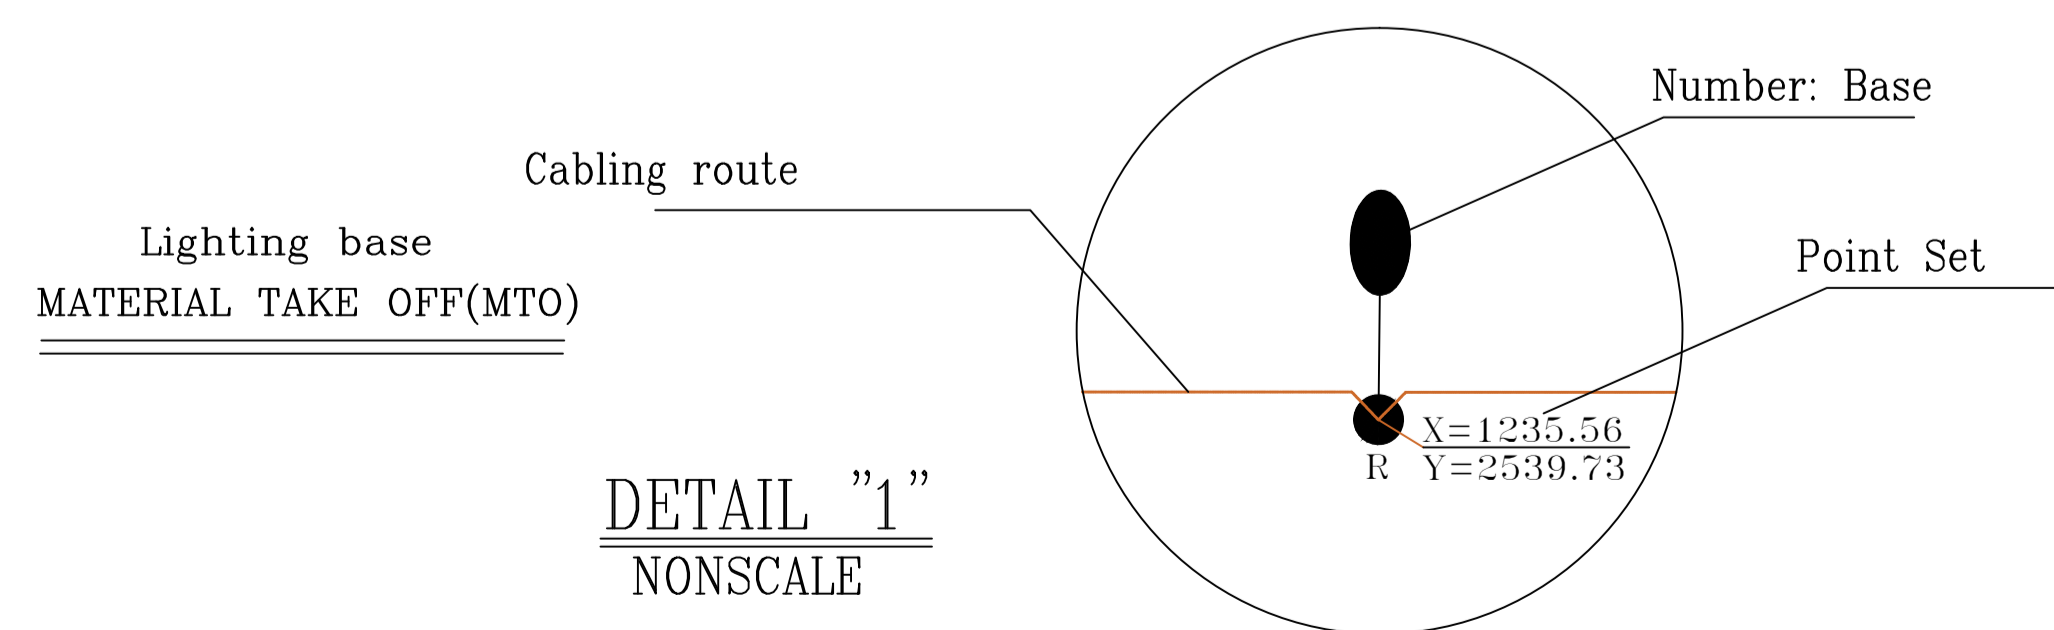

Rev.	Date	Issued for Approval Revisions description	P.S.Co. Designed by	P.S.Co. Checked by	A. Karimi Approved
0	1400/03/22				

کارفرما: شرکت آهن و فولاد ارفع

طراح: شرکت فنی مهندسی پیرامون صنعت

عنوان پروژه: روشنایی جاده احیا

عنوان: LIGHTING LAYOUT

Contractual Item		Drawing Title:	
Designed by	H.HASANI	1400/03/22	
Checked by	P.S.Co.	1400/03/22	
Drawn by	H.HASANI	1400/03/22	Client Number:
Approved1	A. KARIMI	1400/03/22	Scale Size Dwg. Number:
Approved2	A. KARIMI	1400/03/22	AS SHOWN A1

Sheet/Follow: 2/2

COMPUTER AIDED DESIGN